


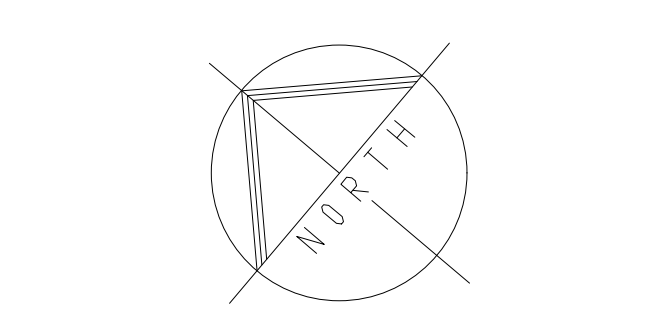



- NOTES:
1. THE ENTIRE CONDUIT, CABLE TRAY AND SLEEVE INFRASTRUCTURE FOR THE VOICE AND DATA INSTALLATION WILL BE DONE BY THE ELECTRICAL CONTRACTOR.
 2. THE ELECTRICAL CONTRACTOR WILL SUPPLY AND INSTALL ALL RECESSED RJ45 VOICE AND DATA OUTLET POINTS.
 3. THE VOICE AND DATA CONTRACTOR MUST CO-ORDINATE WITH THE ELECTRICAL CONTRACTOR WHICH SLEEVES CAN BE USED FOR THE VOICE AND DATA INSTALLATION. ANY SLEEVES AS PROVIDED FOR OTHER SERVICES THAN VOICE AND DATA CABLEING MAY NOT BE USED BY THE VOICE AND DATA CONTRACTOR.
 4. ALL SLEEVES INSIDE THE BUILDINGS AS SUPPLIED BY THE ELECTRICAL CONTRACTOR WILL BE COMPLETE WITH DRAW WIRES.

THIS DRAWING IS TO BE READ IN CONJUNCTION WITH THE FOLLOWING ENGINEERING SERVICE ONLY:

VOICE & DATA INSTALLATION



NO.	REVISIONS	APPROVED	DATE
CLIENT			
MINISTRY OF WORKS AND TRANSPORT			
			
REPUBLIC OF NAMIBIA			
PRIVATE BAG 13341 WINDHOK			
APPROVED			
COPYRIGHT RESERVED			
CONSULTANTS			
ARCHITECT			
CLARKE ARCHITECTS			
P.O. BOX 30154 WINDHOK			
TEL: (061) 481 428 FAX: (061) 481 408 email: clarke@clarke-architects.com			
QUANTITY SURVEYOR			
BLOKKER JACOBS & KUSCHKE QUANTITY SURVEYORS			
P.O. BOX 9215 WINDHOK			
TEL: (061) 258 728 FAX: (061) 254 822 email: jk@bkkj.com.na			
CIVIL & STRUCTURAL ENGINEER			
VINYL COAST CONSULTING ENGINEERING			
P.O. BOX 2773 WINDHOK			
TEL: (064) 455 600 FAX: (064) 455 599 email: vinyl@vinyl.co.na			
ELECTRICAL AND MECHANICAL ENGINEERS			
			
P.O. BOX 2142 WINDHOK			
TEL: (0646) 220 145 FAX: (0646) 220 146 email: gfa@gef.co.na			
PROJECT			
CONSTRUCTION OF NEW REGIONAL MICT OFFICES IN MARIENTAL, HARDAP REGION			
DRAWING TITLE			
GROUND FLOOR VOICE & DATA LAYOUT AND DISTRIBUTION FRAME DIAGRAM			
ELECTRICAL INSTALLATION			
CONSULTANT PROJECT NO.: 5280			
DESIGNED: SWPL		DRAWN: MA	
CHECKED: ES		DATE: 09/03/2016	
SCALE: 1:50		DRAWING NO.: 5280/1002/EE-V0	
VOL: 00			